






SABER ENGINEERING
 2923 South Tryon Street Suite 280
 Charlotte, North Carolina 28203
 tel 704.373.0068
 MECHANICAL ELECTRICAL PLUMBING

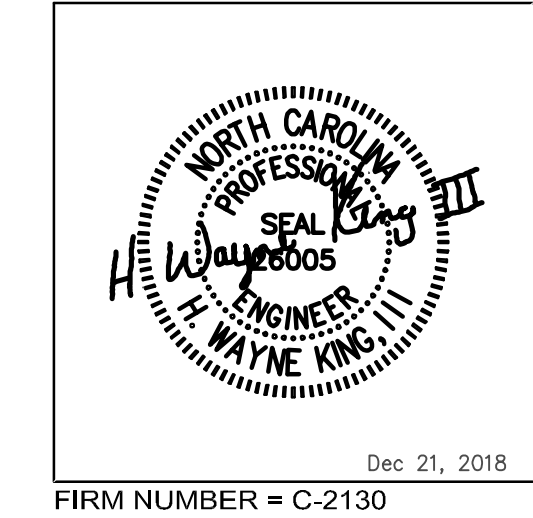

FIRM NUMBER = C-2130

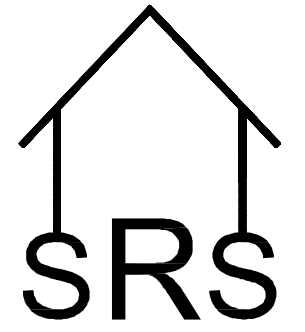

SOLID ROCK STRUCTURAL PLLC
 SCOTT WESTMORELAND, P.E.
 71 GLENN HILL LANE HIDDENITE, N.C. 28636
 PHONE: 704-819-6415
 FAX: 704-585-6529
 SCOTT@SOLIDROCKSTRUCTURAL.COM
 FIRM LICENSE NO. P-0390

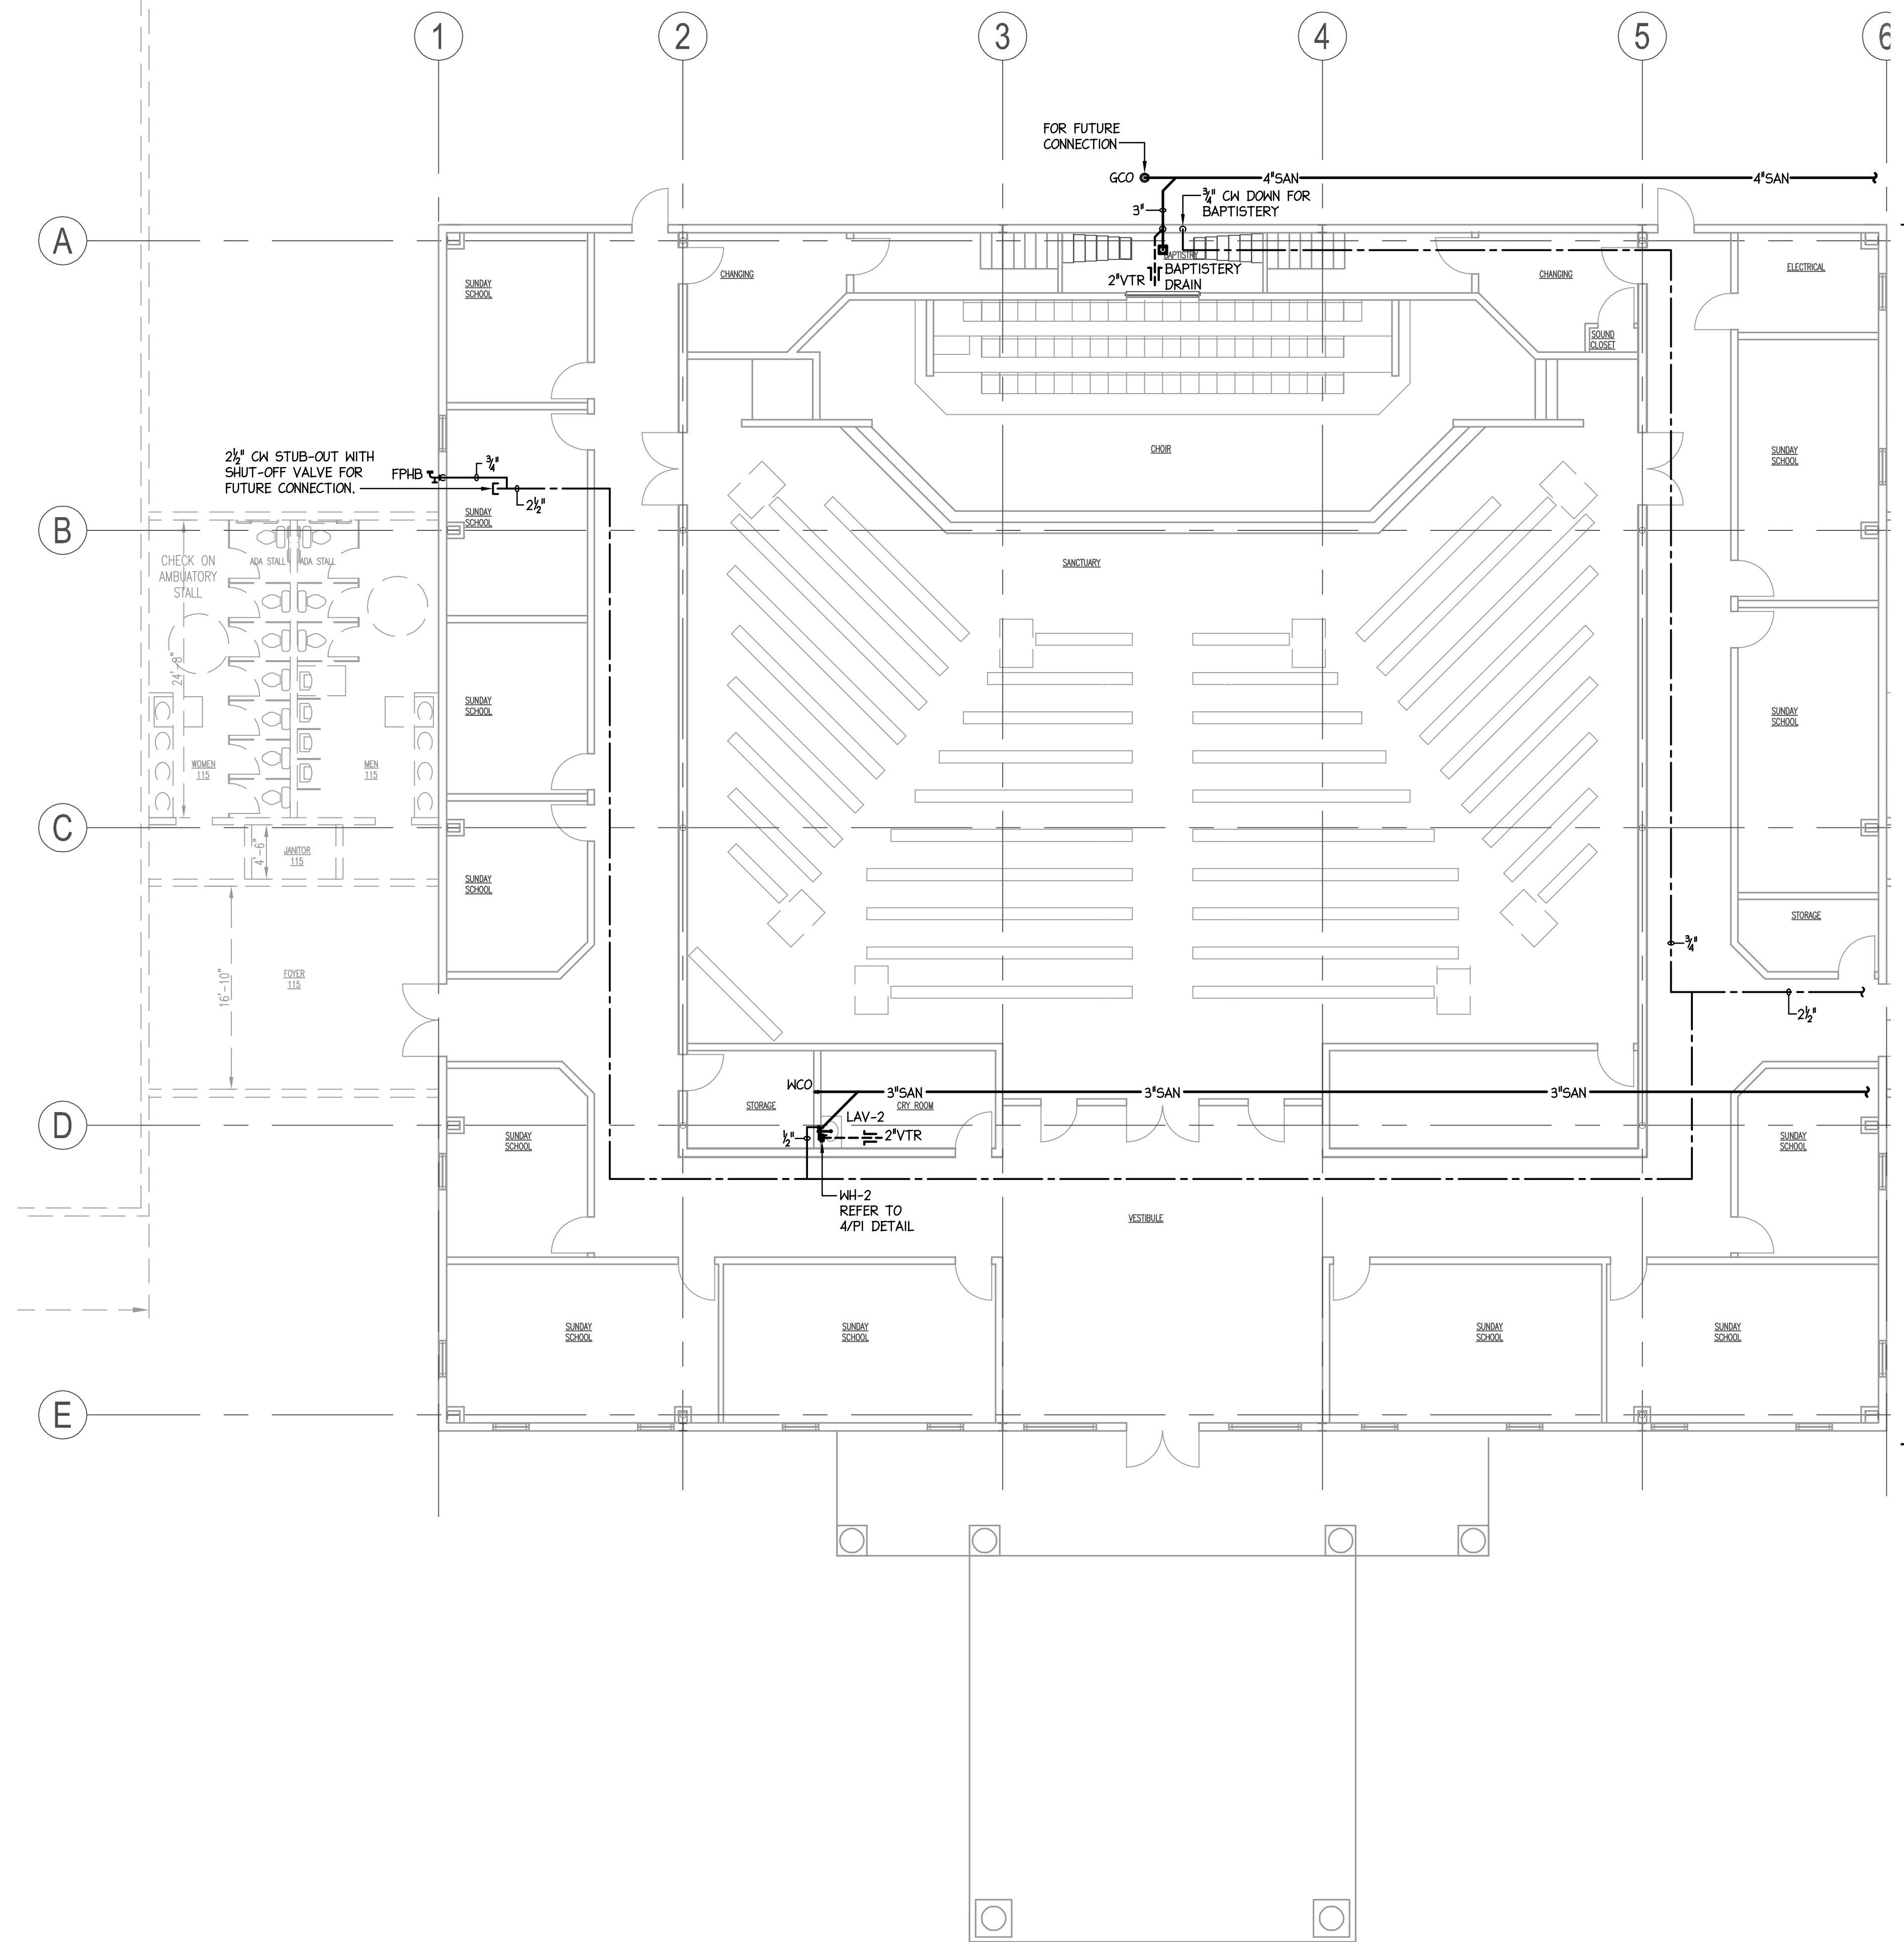

REFER TO SHEET P2 FOR CONTINUATION

STONY POINT TABERNACLE

235 MINT HILL CT.
 STONY POINT, NC

© Copyright
 THIS DOCUMENT IS THE PROPERTY OF SOLID ROCK STRUCTURAL, AND IS NOT TO BE REPRODUCED OR COPIED IN WHOLE OR IN PART. IT IS TO BE USED FOR THE PROJECT AND/OR SITE SPECIFICALLY IDENTIFIED HEREIN AND NO OTHER. IT IS TO BE RETURNED UPON REQUEST.

DRAWING DATA

DRAWN BY: SABER
 PROJECT NUMBER:
 FILE NUMBER:
 DATE: 12/21/18

REVISION DATA

SHEET TITLE

PLUMBING SANCTUARY PLAN

SHEET NUMBER

P2

1 PLUMBING SANCTUARY PLAN
 1/8" = 1'-0"


TAGGED NOTES - THIS SHEET

- ① DOMESTIC CH. SEE CIVIL PLANS FOR CONTINUATION. LOAD REQUIREMENT AT FACE OF BUILDING = 110 GPM @ 50 PSI
- ② PROVIDE TRANSITION FITTING AS REQUIRED TO MEET CIVIL CONNECTION SIZE
- ③ BUILDING 3" SUPPLY RISER SUPPLY WITH SHUT-OFF VALVE.
- ④ PROVIDE ALL REQUIRED PLUMBING CONNECTIONS FOR DISHWASHER PER MFR RECOMMENDATIONS. PROVIDE DRAIN QUENCH SYSTEM IF TEMPERATURES OVER 140°F ARE ACHIEVED, COORDINATE WITH OWNER/SUPPLIER.
- ⑤ PROVIDE SECONDARY BACKFLOW WATTS MODEL SD-3 WITH SHUT OFF VALVE.




2923 South Tryon Street Suite 280
Charlotte, North Carolina 28203
tel 704.373.0068


MECHANICAL ELECTRICAL PLUMBING

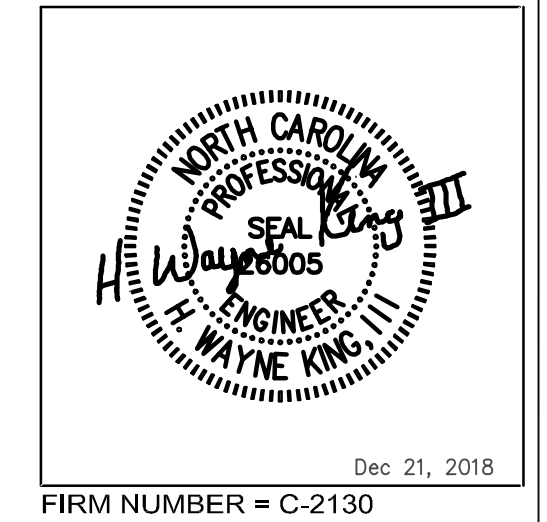

Dec 21, 2018
FIRM NUMBER = C-2130

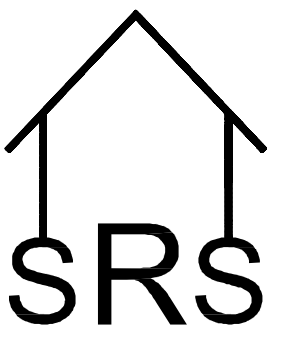


SOLID ROCK STRUCTURAL PLLC
SCOTT WESTMORELAND, P.E.
71 GLENN HILL LANE HIDDENITE, N.C. 28636
PHONE: 704-819-6415
FAX: 704-585-6529
SCOTT@SOLIDROCKSTRUCTURAL.COM
FIRM LICENSE NO. P-0390

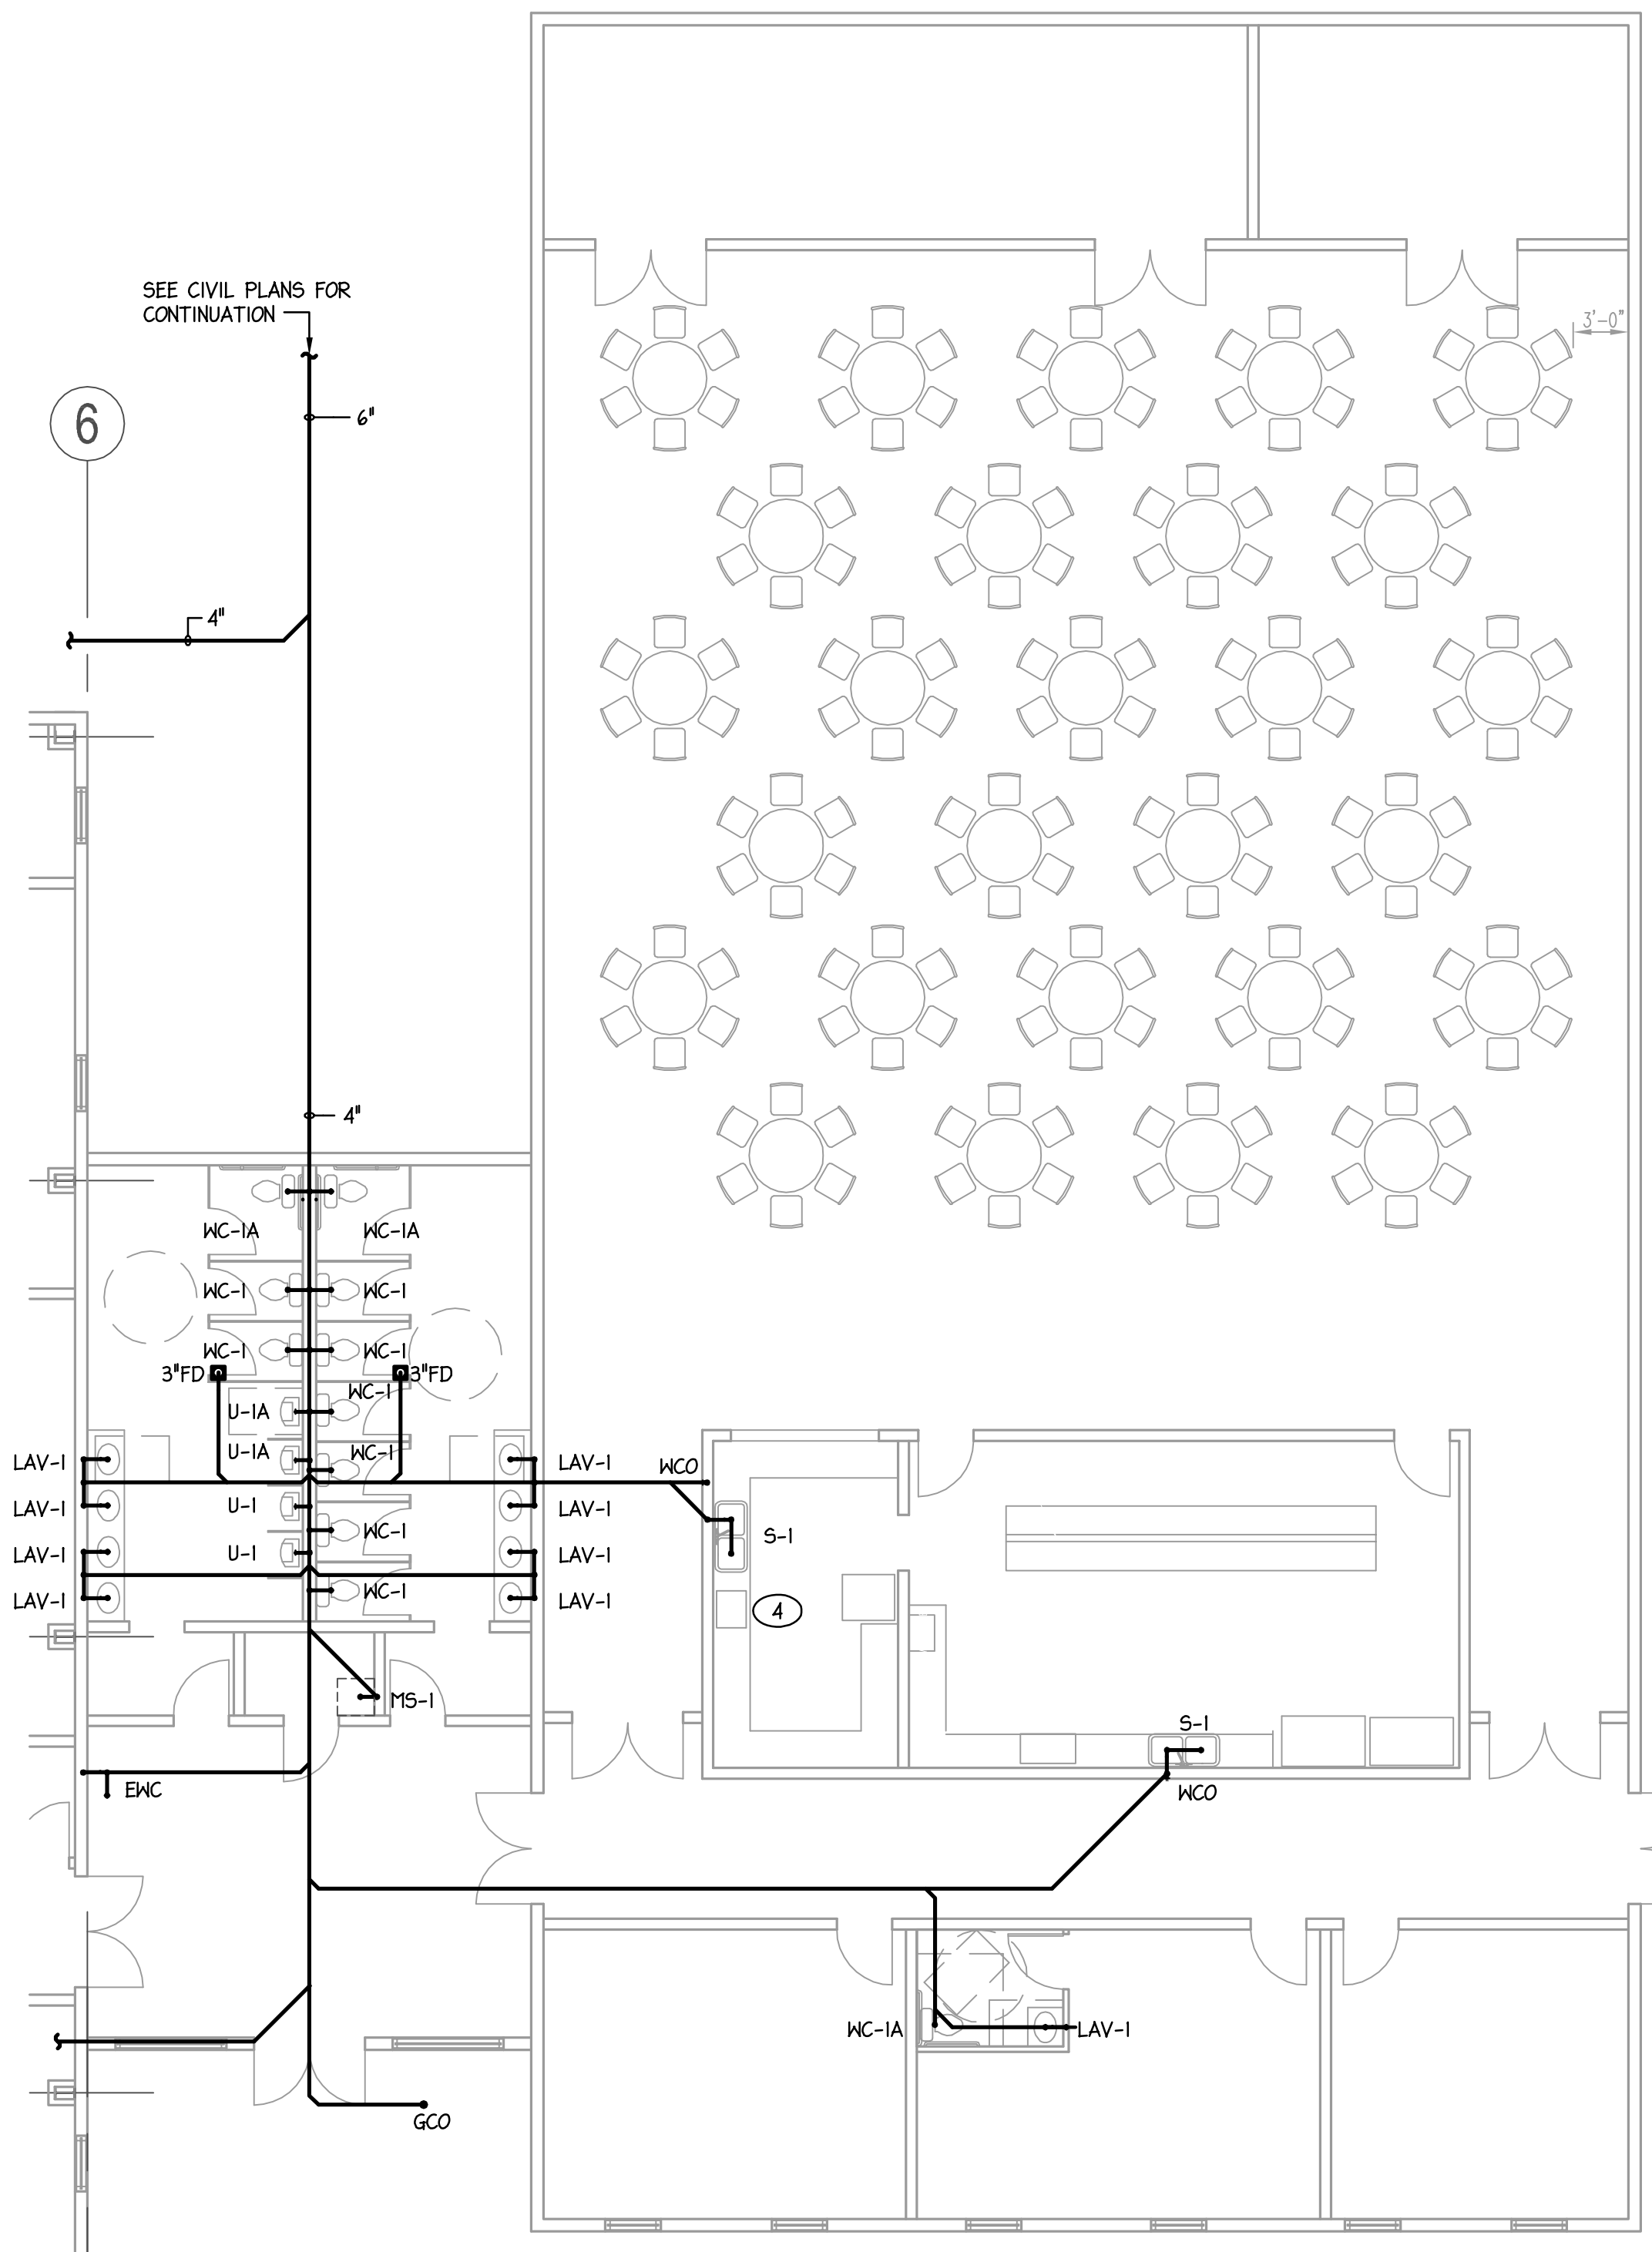

1 PLUMBING FELLOWSHIP HALL SANITARY PLAN
1/8" = 1'-0"

REFER TO SHEET P4 FOR ADDITIONAL INFORMATION

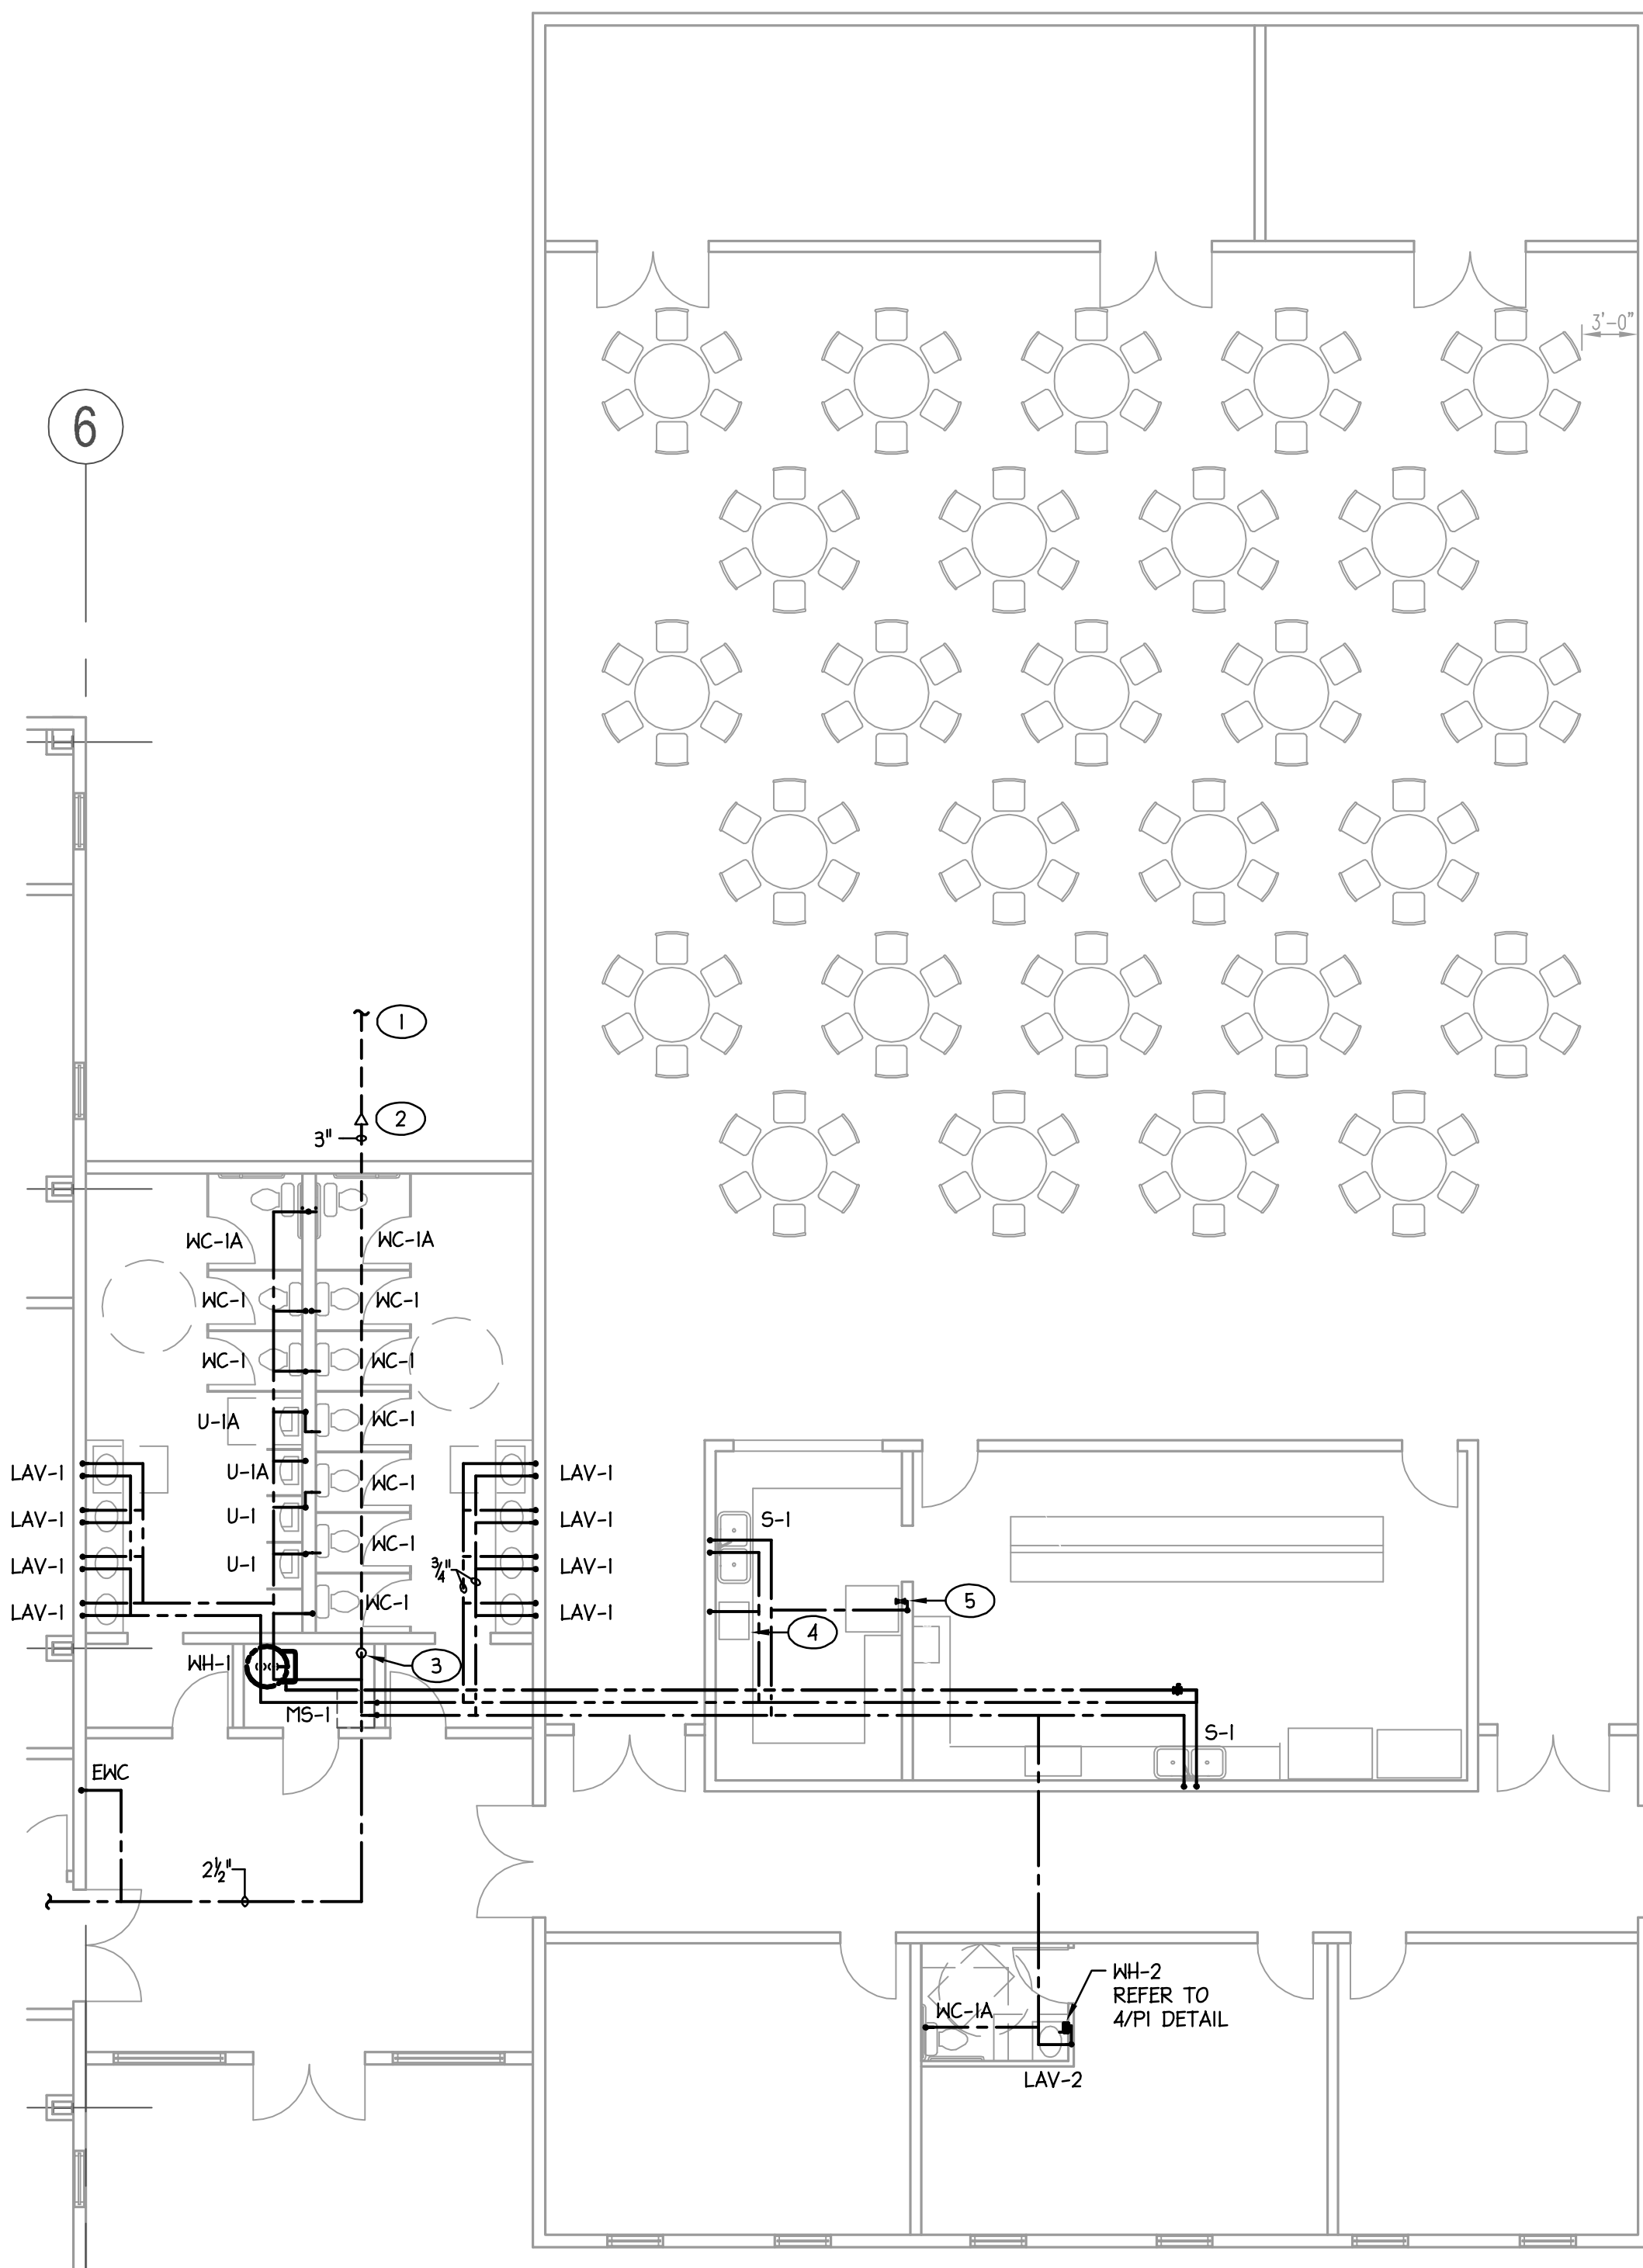

2 PLUMBING FELLOWSHIP HALL SUPPLY PLAN
1/8" = 1'-0"

REFER TO SHEET P4 FOR ADDITIONAL INFORMATION

**STONY POINT
TABERNACLE**

235 MINT HILL CT.
STONY POINT, NC

© Copyright
THIS DOCUMENT IS THE PROPERTY OF SOLID ROCK STRUCTURAL, AND IS NOT TO BE REPRODUCED OR COPIED IN WHOLE OR IN PART. IT IS TO BE USED FOR THE PROJECT AND/OR SITE SPECIFICALLY IDENTIFIED HEREIN AND NO OTHER. IT IS TO BE RETURNED UPON REQUEST.

DRAWING DATA

DRAWN BY: SABER
PROJECT NUMBER:
FILE NUMBER:
DATE: 12/21/18


REVISION DATA

SHEET TITLE


PLUMBING SANCTUARY
PLAN

SHEET NUMBER

P3

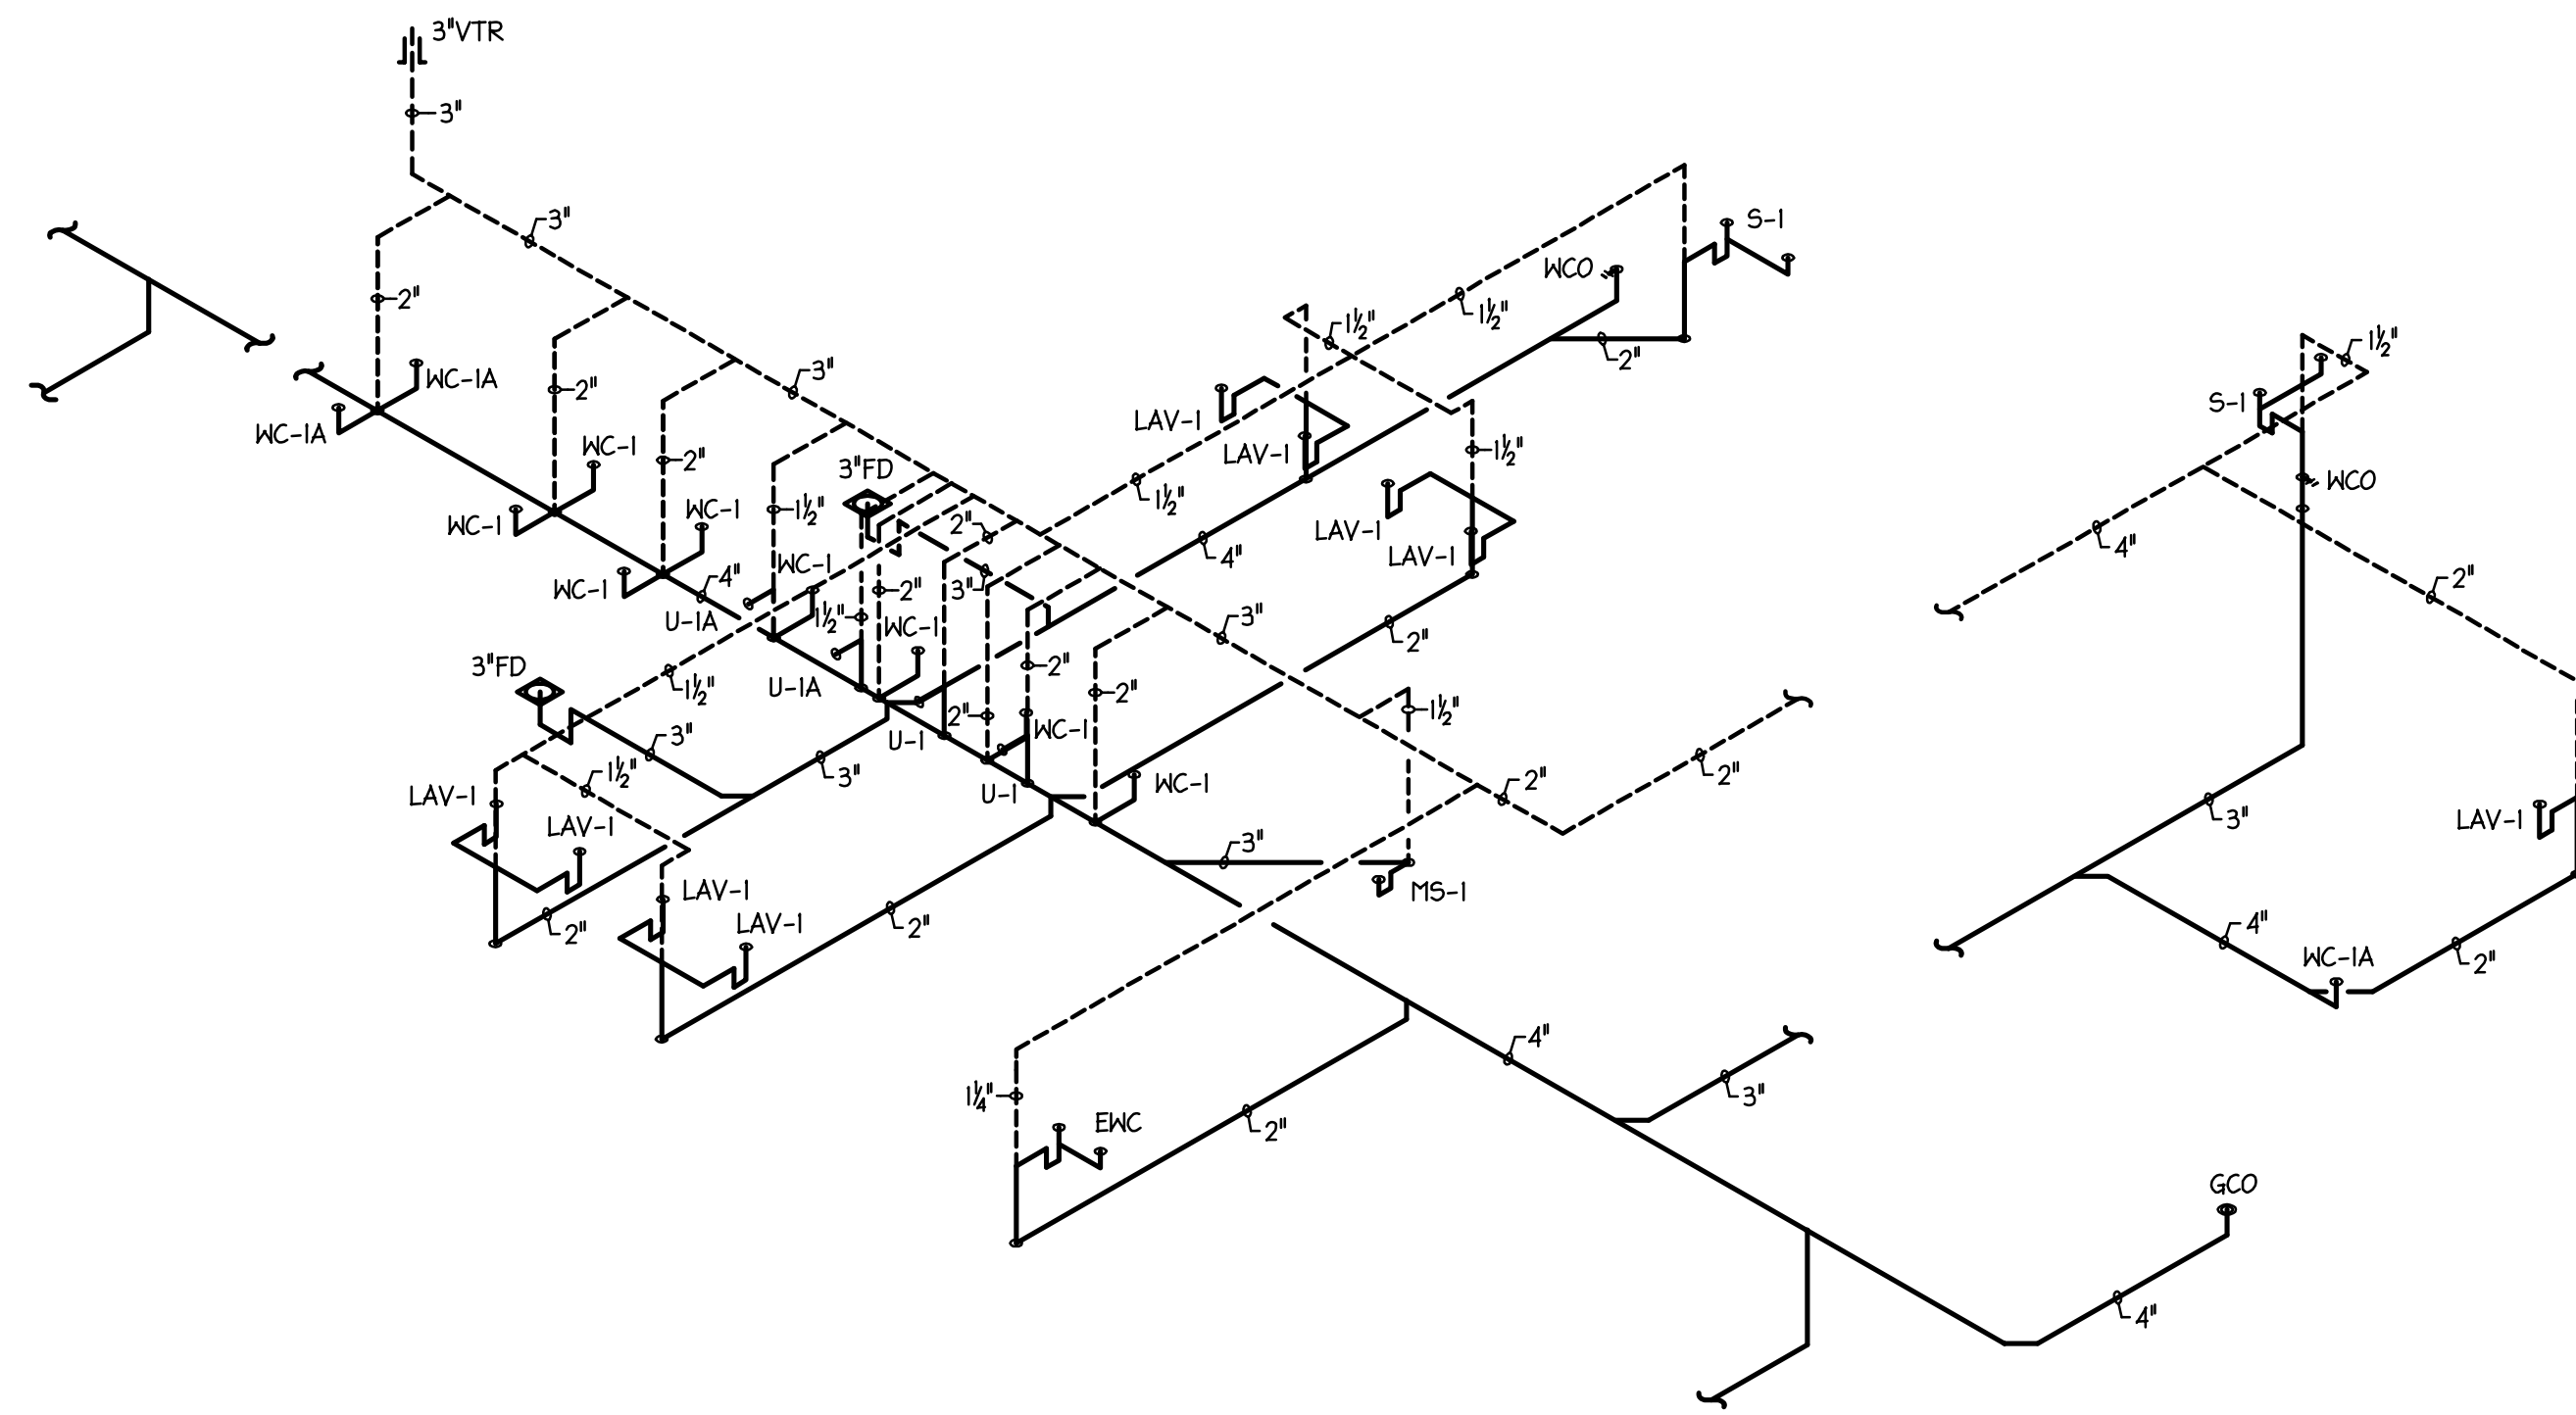

1 WASTE/VENT RISER DIAGRAM
N.T.S.

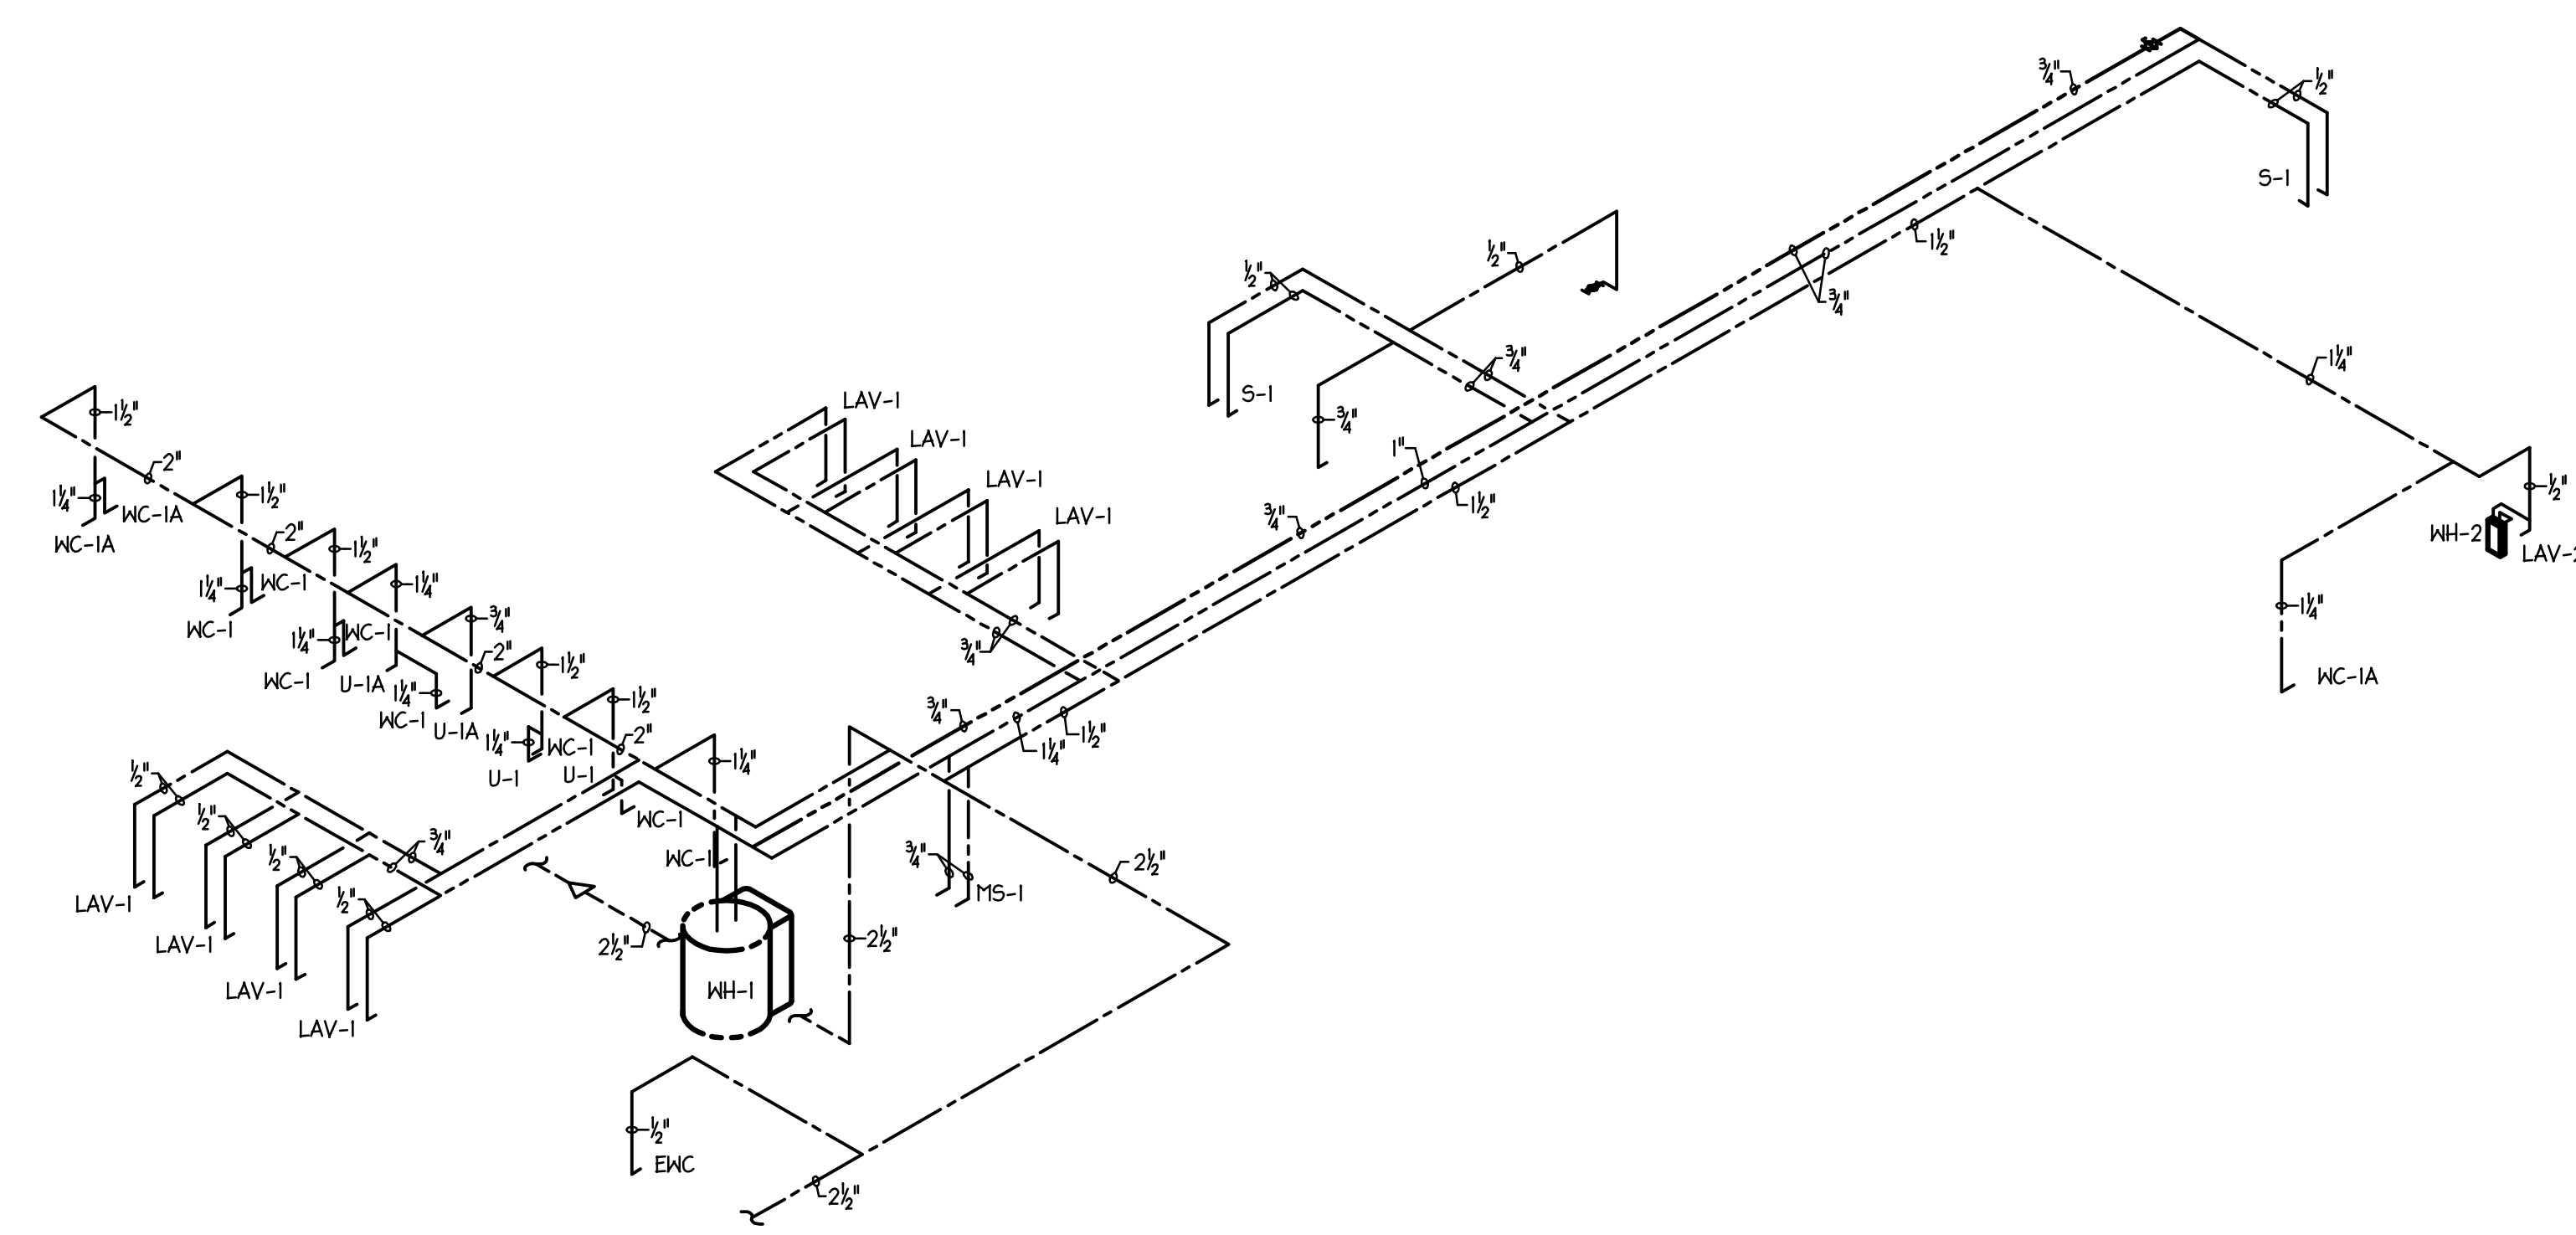


2 PLUMBING FELLOWSHIP HALL SUPPLY PLAN
1/8" = 1'-0"




SABER ENGINEERING
2923 South Tryon Street Suite 280
Charlotte, North Carolina 28203
tel 704.373.0068

MECHANICAL ELECTRICAL PLUMBING

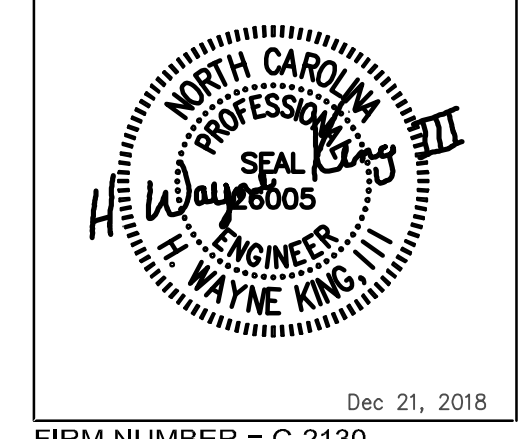

Dec 21, 2018
FIRM NUMBER = C-2130

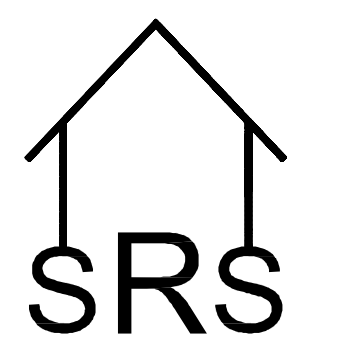

SOLID ROCK STRUCTURAL PLLC
SCOTT WESTMORELAND, P.E.
71 GLENN HILL LANE HIDDENITE, N.C. 28636
PHONE: 704-819-6415
FAX: 704-585-6529
SCOTT@SOLIDROCKSTRUCTURAL.COM
FIRM LICENSE NO. P-0390

STONY POINT TABERNACLE

235 MINT HILL CT.
STONY POINT, NC

© Copyright
THIS DOCUMENT IS THE PROPERTY OF SOLID ROCK STRUCTURAL, AND IS NOT TO BE REPRODUCED OR COPIED IN WHOLE OR IN PART. IT IS TO BE USED FOR THE PROJECT AND/OR SITE SPECIFICALLY IDENTIFIED HEREIN AND NO OTHER. IT IS TO BE RETURNED UPON REQUEST.

DRAWING DATA	
DRAWN BY:	SABER
PROJECT NUMBER:	
FILE NUMBER:	
DATE:	12/21/18

REVISION DATA	

SHEET TITLE
PLUMBING
RISER
DIAGRAMS

SHEET NUMBER

P4